
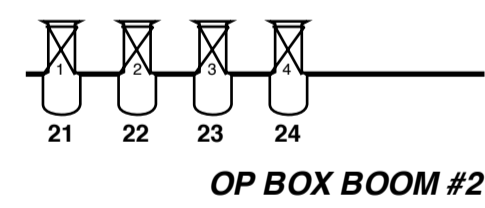
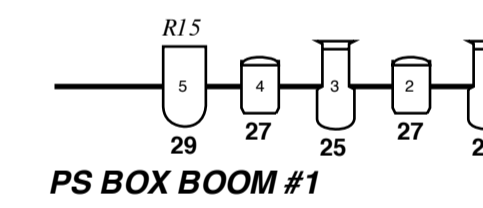
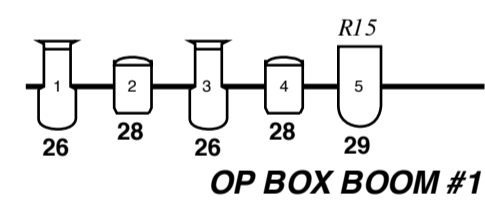



KEY

- | | | | |
|--|----------------|--|-----------------|
| | Pacific 12-28 | | Rama F |
| | Pacific 5.5-13 | | Arena F |
| | Pacific 23-50 | | PAR64 MFL |
| | Rama PC | | Aurora Cyc Cell |


Color
Channel

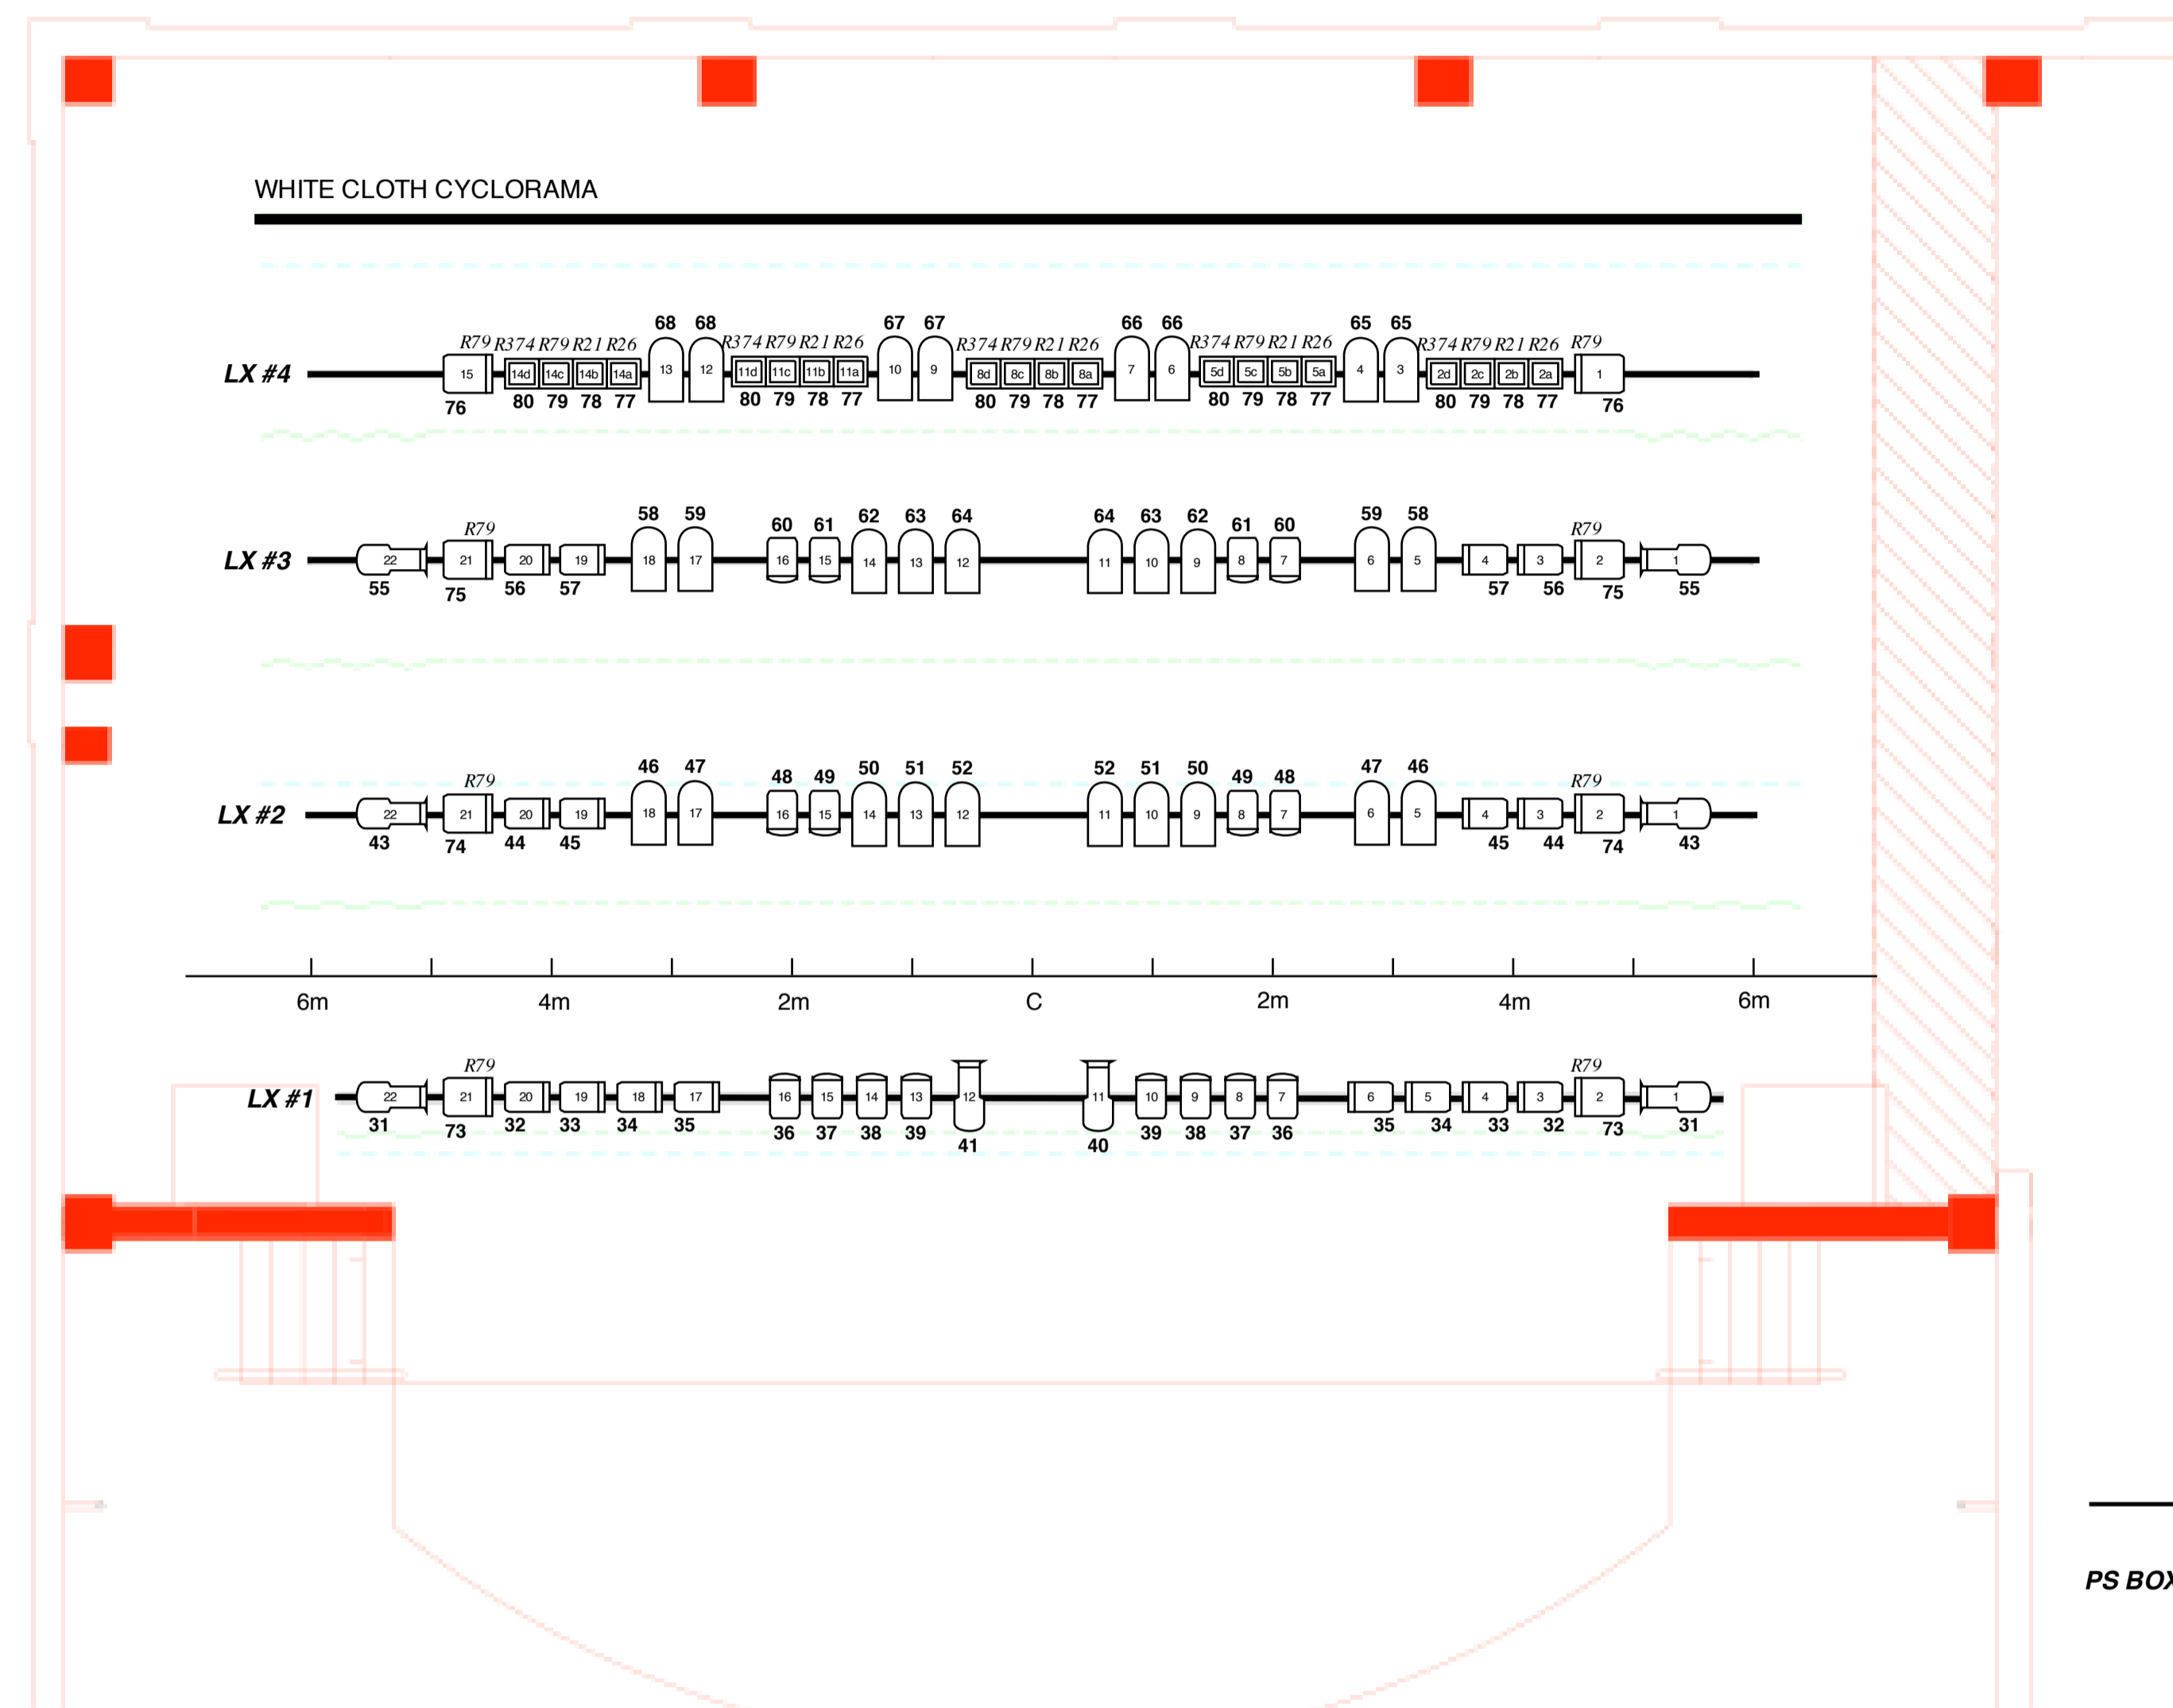

ACTUAL POSITON 9500 FROM SETTING LINE

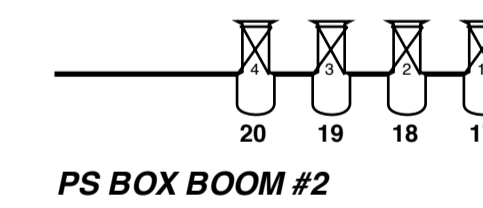

ACTUAL POSITON 9500 FROM SETTING LINE

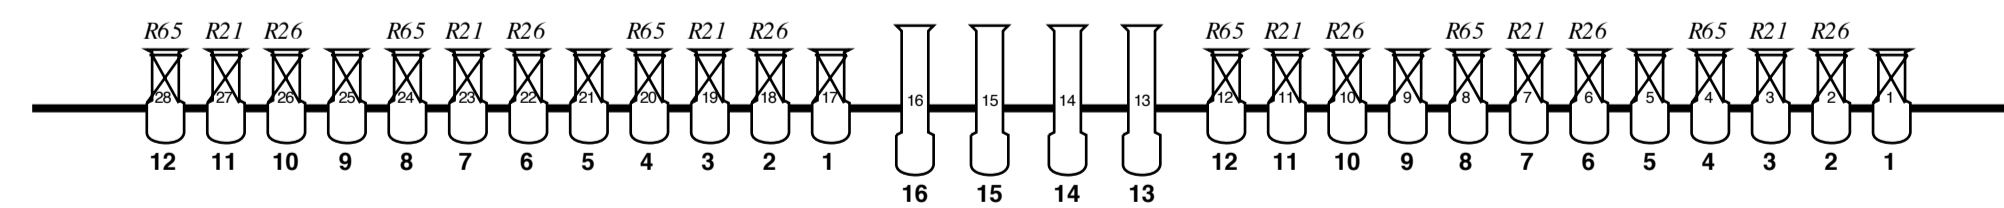

ACTUAL POSITION 13750 FROM SETTING LINE

STANDARD LIGHTING PLAN CAPITOL THEATRE - TAMWORTH

DRAWN: BJH CHECKED: RS
03/05/09 SCALE: 1:50 @ A1 FOH NOT TO SCALE

